

SCALE 1/8" = 1'-0"

#192	DIG. SIGNATURE
ive Classifier	Date

KEYPLAN - BLDG X-330

CAD OVERLAY

1 REFER TO DWG# X-330-5201M FOR GENERAL NOTES AND LEGEND  
2 ALL ELEVATIONS FROM FINISHED FLOOR  
3 \* - THIS EXISTING TROUGH REQUIRES NO MODIFICATION  
4 MANIFOLD PIPING IS SUPPORTED FROM DUCT EDGE ANGLE STIFFENER  
5 MANIFOLD PIPING IS SUPPORTED FROM EXISTING CABLE TRAY NEXT TO  
6 PVC MANIFOLD PIPING SUPPORTED FROM EXISTING BUILDING  
STEEL ABOVE

	1	10	19	28	37	46	55	64	73	82	90
A											
H	5202M	5206M	5210M	5214M	5218M	5222M	5226M	5230M	5234M	5238M	
Q	5203M	5207M	5211M	5215M	5219M	5223M	5227M	5231M	5235M	5239M	
Y	5204M	5208M	5212M	5216M	5220M	5224M	5228M	5232M	5236M	5240M	
	5205M	5209M	5213M	5217M	5221M	5225M	5229M	5233M	5237M	5241M	

KEYPLAN - BLDG X-330



CAD OVERLAY

UNITED STATES DEPARTMENT OF ENERGY

**MARTIN MARIETTA** MARTIN MARIETTA ENERGY SYSTEMS INC.

P.O. BOX 628 PIKETON, OHIO 45661

PROJECT RED PCB CONTAM. VENT DUCT

91	SUBPROJECT	EXHAUST DUCT TROUGHS
----	------------	----------------------


BUILDING X-330 PIPING PLAN

COLUMNS 10A THRU 19H

SCALE AS NOTED	DWG NO Y 330 E306M	REV A01
-------------------	-----------------------	------------

AD NOTED	X 336 520011	
----------	--------------	--

"NO REPRESENTATION OR WARRANTY, EXPRESSED OR IMPLIED, IS MADE THAT THE USE OR DISCLOSURE OF ANY INFORMATION, APPARATUS, METHOD OR PROCESS DISCLOSED IN THESE DRAWINGS MAY NOT INFRINGE PRIVATE RIGHTS OF OTHERS. NO LIABILITY IS ASSUMED WITH RESPECT TO THE USE OF OR FOR DAMAGES RESULTING FROM THE USE OF, ANY INFORMATION, APPARATUS, METHOD OR PROCESS DISCLOSED IN THESE DRAWINGS. THE DRAWINGS ARE BEING MADE AVAILABLE FOR INFORMATION AND BIDDING PURPOSES ONLY AND FOR OTHER PURPOSES, AND ARE TO BE RETURNED UPON REQUEST OF THE FORWARDING CONTRACTOR."

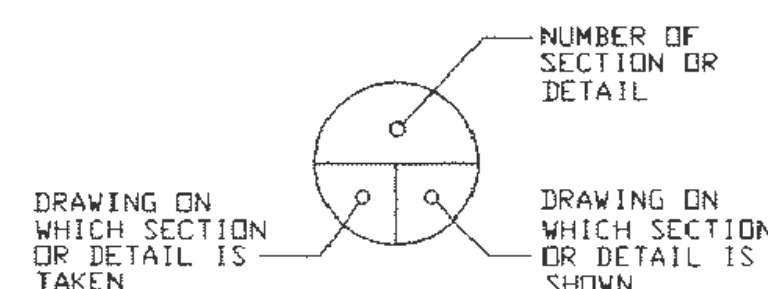

SECTION &amp; DETAIL KEY

**LOCKWOOD GREENE**  
**RECKONING TOGETHER**

APPROVAL S D STETHEN <sup>SD</sup> PROJ NO 643090

[illegible]

	APPROVALS	DATE
	R LAMB DRAWN	9/8
	D J HALL CHECKED	9/9
	W HEYWARD ENG	9/9
GN.	D G BEATON SURV	11/13
23-96	F A CASE MM-ES	11/26
9/1		
DATE		
TE	DOE	

UNITED STATES DEPARTMENT OF ENERGY			
MARTIN MARIETTA		MARTIN MARIETTA ENERGY SYSTEMS INC	
P O BOX 628 PIKETON, OHIO 45661 ACTING UNDER CONTRACT DE-AC09-76DP00001 WITH THE U.S. DEPARTMENT OF ENERGY			
PROJECT	RED PCB CONTAM. VENT DUCT		
SUBPROJECT	EXHAUST DUCT TROUGHS		
TITLE	BUILDING X-330 PIPING PLAN COLUMNS 10A THRU 19H		
SCALE	DWG NO		REV
AS NOTED	X-330-5206M		A01