

SCALE 1/8" = 1'-0"

#192 DIG. SIGN  
 \_\_\_\_\_  
 Date

KEYPLAN - BLDG X-330



## REFERENCE DRAWINGS

A01	WKB	DAK	CEF	CFC PER ESO E6663-001
/	ES	DK	JR	GENERAL REVISION, AS-BUILT CONTINUATION IN VENT DET.
0		WBH	DGB	CERTIFIED FOR
REV	DWN	ENG	CHK'D	DI

	APPROVALS	DATE
	R LAMB DRAWN	9/12/25
	S PRICE CHECKED	9/12/25
	W HEYWARD ENG	9/17/25
IGN.	D G BEATON SUVP	11/13/25
3-66	F A CASE MM-ES	11/26/25
/51		
DATE:		
E	DOE	


PROJECT RED PCB CONTAM VENT DUC  
SUBPROJECT EXHAUST DUCT TROUGHS

BUILDING X-330 PIPING PLAN  
COLUMNS 28A THRU 37H

SCALE	DWG NO
AS NOTED	X-330-5214M

AC

"NO REPRESENTATION OR WARRANTY, EXPRESSED OR IMPLIED, IS MADE THAT THE USE OR DISCLOSURE OF ANY INFORMATION, APPARATUS, METHOD OR PROCESS DISCLOSED IN THESE DRAWINGS MAY NOT INFRINGE PRIVATE RIGHTS OF OTHERS. NO LIABILITY IS ASSUMED WITH RESPECT TO THE USE OF OR FOR DAMAGES RESULTING FROM THE USE OF, ANY INFORMATION, APPARATUS, METHOD OR PROCESS DISCLOSED IN THESE DRAWINGS. THE DRAWINGS ARE NOT TO BE USED FOR INFORMATION BY A BIDDER AND ARE NOT TO BE USED FOR OTHER PURPOSES, AND ARE TO BE RETURNED UPON REQUEST OF THE FORWARDING CONTRACTOR."

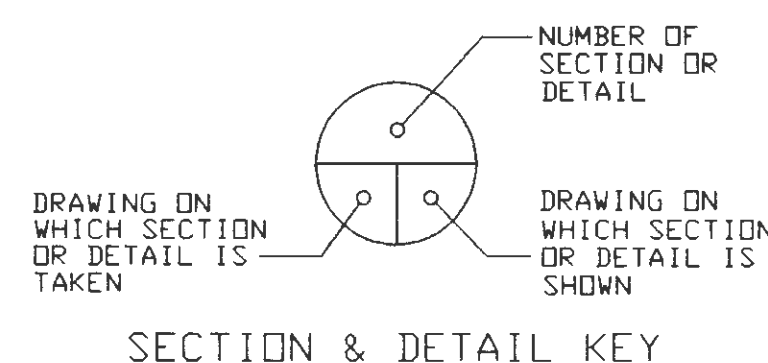

**LOCKWOOD GREENE**