


- NOTES:
1. FOR KEY PLAN & GENERAL NOTES SEE DWG. X-330-4200M.
 2. FOR PIPE SPACING SEE MANHOLE DETAILS ON DWG. X-330-4029M & X-330-4029M.
 3. FOR SECT. 3 SEE DWG. X-330-4029M.
 4. FOR COOLANT MAIN STAIN EXTRACTOR SEE DETAIL 89, DWG. X-330-4029M.

DEMOLITION NOTE:

1. REMOVE:
(SEE DRAWING NO. X-330-4029.10-M.)

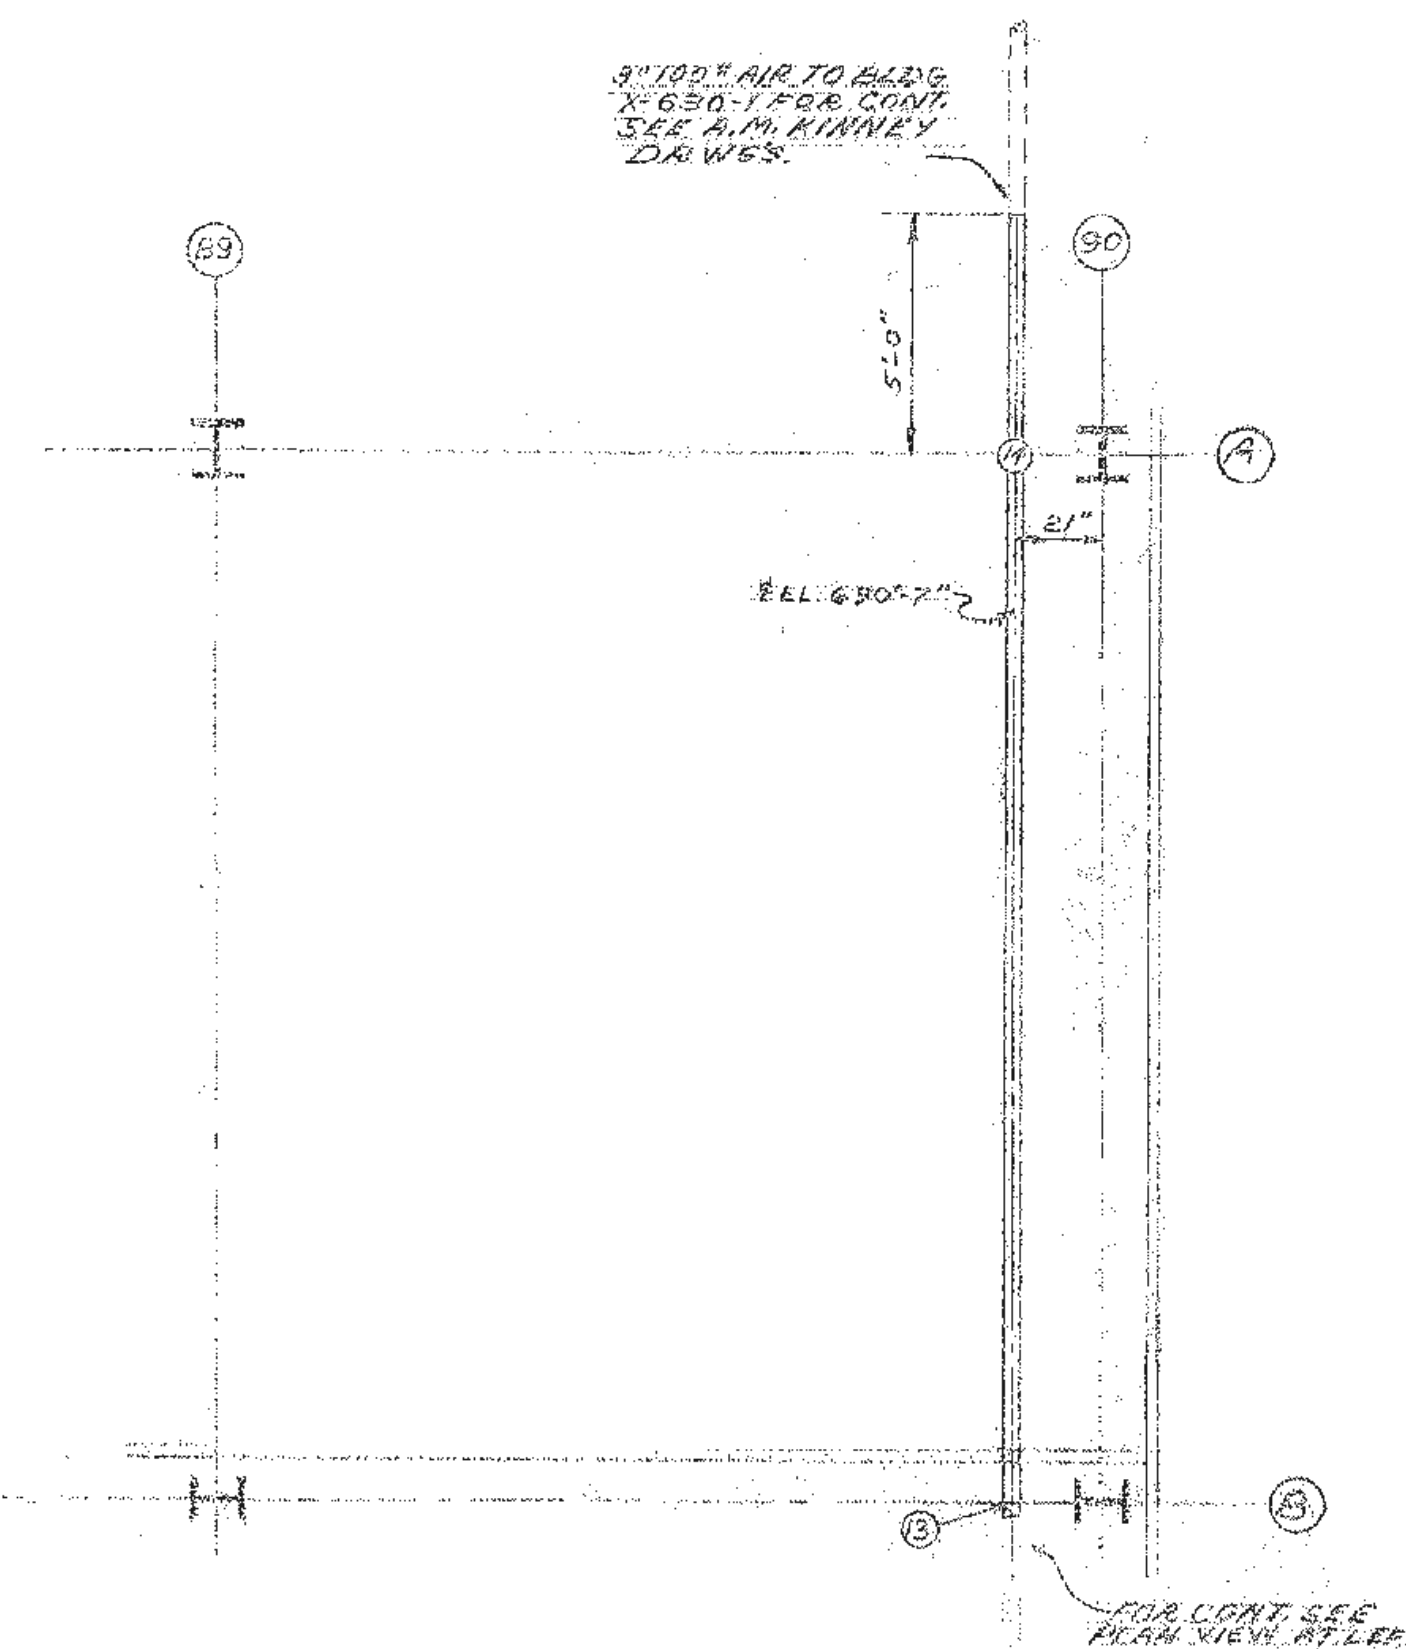

UNCLASSIFIED CONTROLLED NUCLEAR INFORMATION
NOT FOR PUBLIC DISSEMINATION
Unauthorized dissemination subject to civil and criminal sanctions under
Section 148 of the Atomic Energy Act of 1954, as amended (42 U.S.C. 2168).
Reviewing Official: 192 Dated: 10/14/96
(Name/Signature)
Guidance Used: TG-PGD-1 8/96
(List all UCN Guidance used)

* DESIGN MANAGER:
APPROVAL AND DATE:

POOR QUALITY ORIGINAL

BASE DOCUMENT: X 330-4029M, REV. 0 CAD OVERLAY

WKB: A01 6/18/24 CFC PER ESO E6663-001 DAK DIG. SIGN.
AS BUILT AS DERIVED FROM E.P. 1/1/96
REV. NO. DATE ISSUED FOR BY APP. DATE

UNITED STATES
ATOMIC ENERGY COMMISSION
GIFFELS & VALLET, INC.
ENGINEERS
DETROIT 26, MICHIGAN

DRAWING TITLE
PROCESS GAS (P.G.) AUXILIARY SERVICES
AND COOLANT SYSTEM PIPING
GROUND FLOOR PLAN - X-29 SECTION - TYPICAL CELL NUMBER 9

DRAWING APPROVED - DATE	DRAWING APPROVED - DATE	DRAWING APPROVED - DATE
C. G. Giffels 2/1/96 ENGINEER	R. A. Vallet 5/1/96 ENGINEER	L. H. Giffels 3/1/96 ENGINEER
DRAWN BY C. G. Giffels 2/1/96	CHECKED BY R. A. Vallet 5/1/96	DATE 3/1/96
IN CHARGE C. G. Giffels 2/1/96	DATE 5/1/96	DATE 3/1/96
PROJECT X-29 SECTION	BUILDING X 330-4029M	REV A01

SHEET NO. TITLE REFERENCE DRAWINGS